


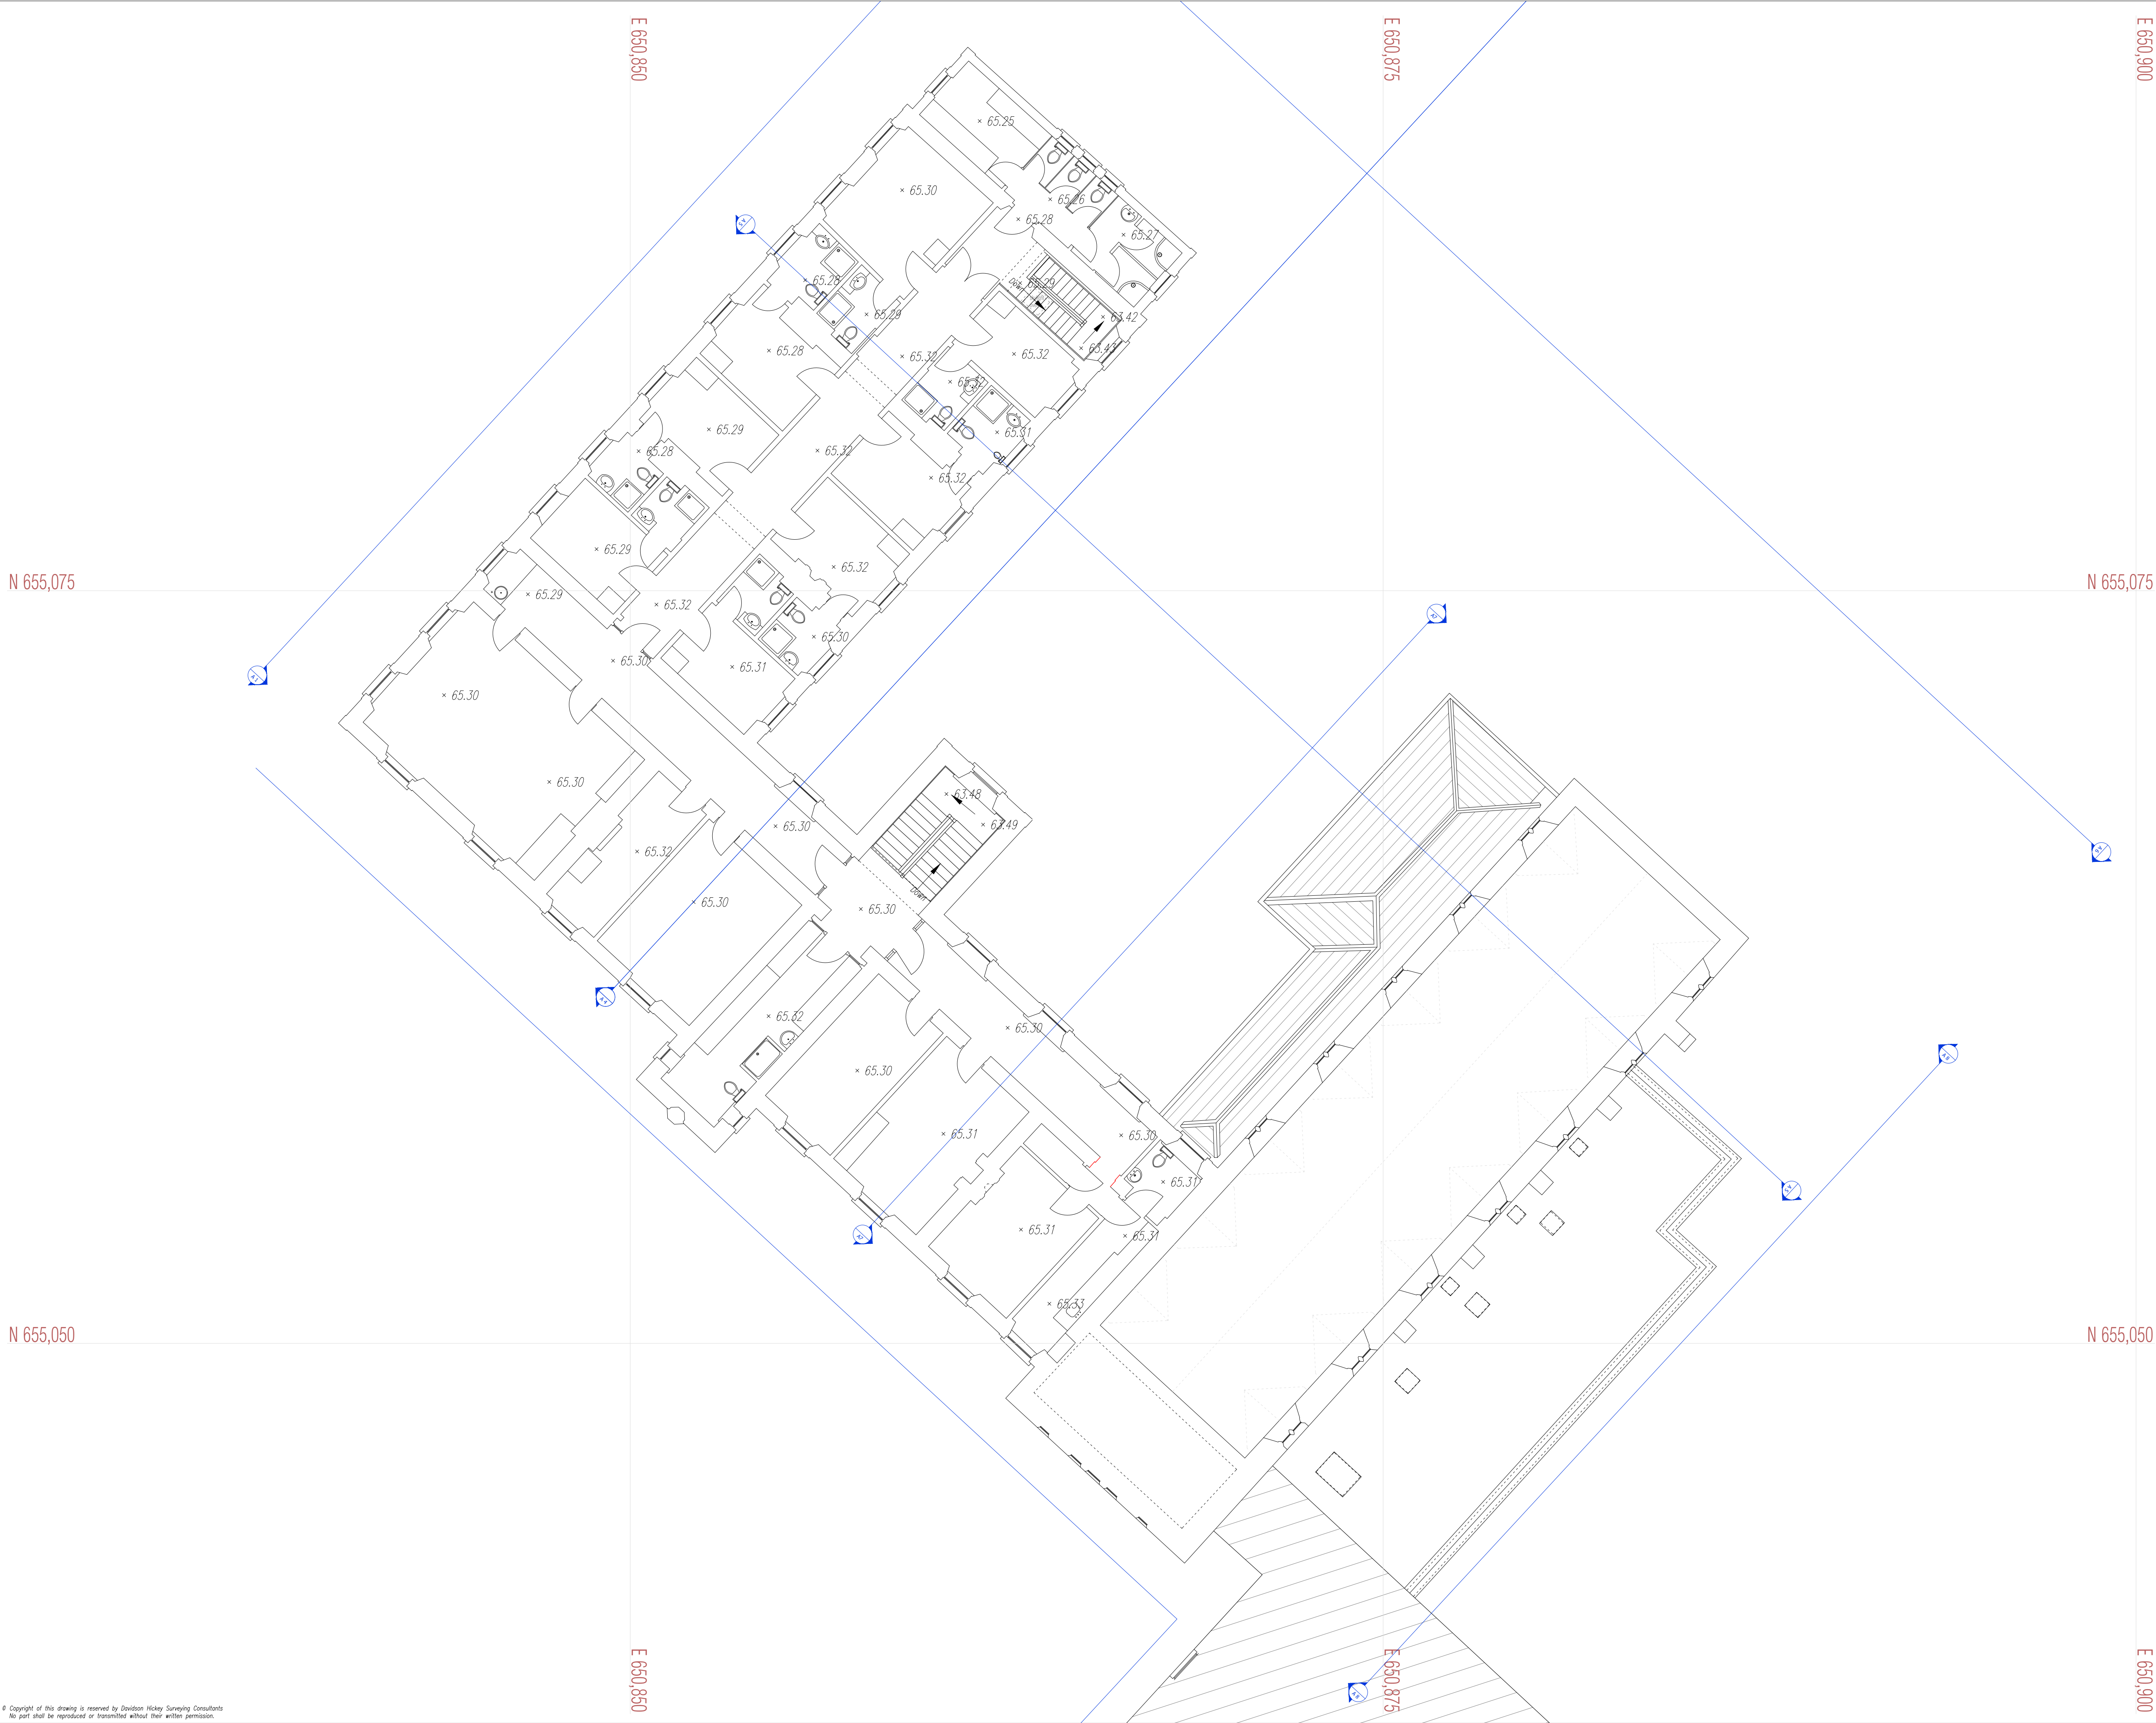

Survey Notes

- All levels are to Mean High Datum.
- 100m Square Grid relative to Irish Transverse Mercator (ITM) Co-ordinate System.
- All dimensions are in meters.
- Only visible services surveyed.
- Any discrepancies in the survey are to be reported to Davidson Hickey Surveying Consultants immediately.
- Do not scale drawing, this shall be permitted in digital form only.

LEGEND

Symbols

- Access Junction	- Flag Pole	- Ridge Height
- Air Valve	- Ground Control Point	- Road Gully
- Bollard	- Ground Floor Level	- Road Sign
- Building Height	- Gully Trap	- Sign
- Bin	- Gas Valve	- Service Box
- Bench Mark	- Hydrant	- ESB Substation
- Security Camera	- Invert Level	- Sluice Valve
- Chimney Height	- Lamp Standard	- Telephone Call Box
- Cable Box	- Manhole	- Telecom Pole
- Cable Pole	- Mini Pillar	- Traffic Signal
- Eaves Height	- Pole	- Well
- Eircom Cover	- Pipe	- Wetland
- Eircom Pole	- ESB Pylon	

Line Types

- Wall Face	- Hedge
- Fence	- White Line
- Overhead Cables	- Yellow Line
- Contour Major	- Double Yellow Line
- Contour Minor	- Building Line

North Arrow

North Arrow pointing towards the top of the page.

Project Information

Rev:	Date:	Details:	By:
DAVIDSON HICKEY Surveying Consultants			
Waterford Office: High Road, Kilmartin, Co. Waterford. Mobile: +353 (0)85 6027995 (Doughla) Phone: +353 (0)51 384808 Fax: +353 (0)51 384808		Kilkenny Office: Dangan, Thomastown, Co. Kilkenny. Mobile: +353 (0)87 2050037 (Mark) Email: info@davidsonhickey.com Web: www.davidsonhickey.com	
Project: St. Joseph's, Deansgrange, Kilkenny.			
Client: Mr. Robert Gilmore		Survey	
Scale: 1:100 @ A1		Drawn: MH	
Co-ordinate System: ITM		Date: December 2022	
Drawing: First Floor Plan		Drawing No.: 003	
		Revision:	

Copyright

© Copyright of this drawing is reserved by Davidson Hickey Surveying Consultants
No part shall be reproduced or transmitted without their written permission.