

SURVEY

Notes

1. Copyright Reserved
2. Work to figured dimensions only. Do not scale drawing.
3. The contractor is responsible for checking all levels and dimensions on site
4. for details of r.c. structure, or mech/electrical details, see Engineers drawings
5. Proprietary items shall be fixed in strict accordance with manufacturers instructions.
6. Sizes of proprietary items shall be checked with manufacturer.
7. The contractor shall be responsible for coordination of structure, finishes and services.

Project

**Change of use and alteration/extension to
16 & 16B Moundown Road, Manor Estate, D12.**

Drawing Title

Existing Ground & First Floor Plans

Drawing No

19-014/S002

Scale

1-100@A3

Rev	0
-----	---

0

Drawn	TC
-------	----

TC

Date

AUGUST 2019



The House Architects

Architecture & Project Management



www.thehousearchitects.ie


**Father Mathew Hall, 131 Church Street,
Smithfield, Dublin 7 tel. 01 507 9990**

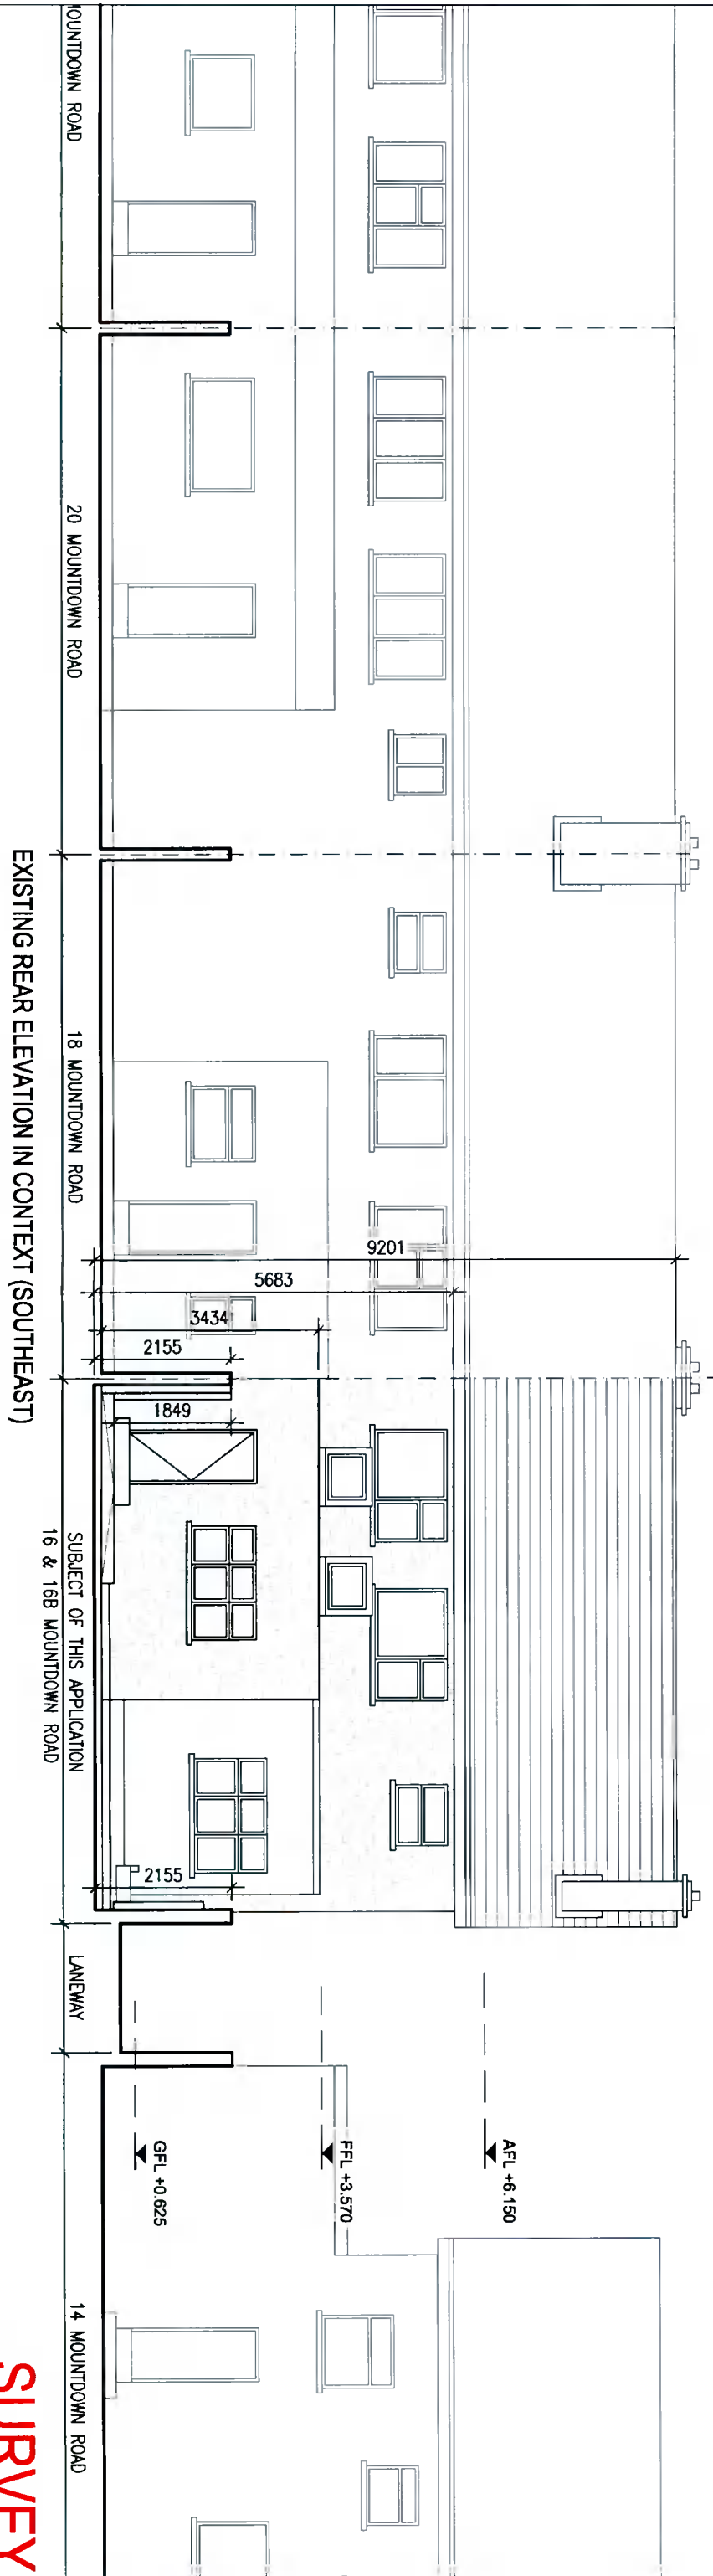
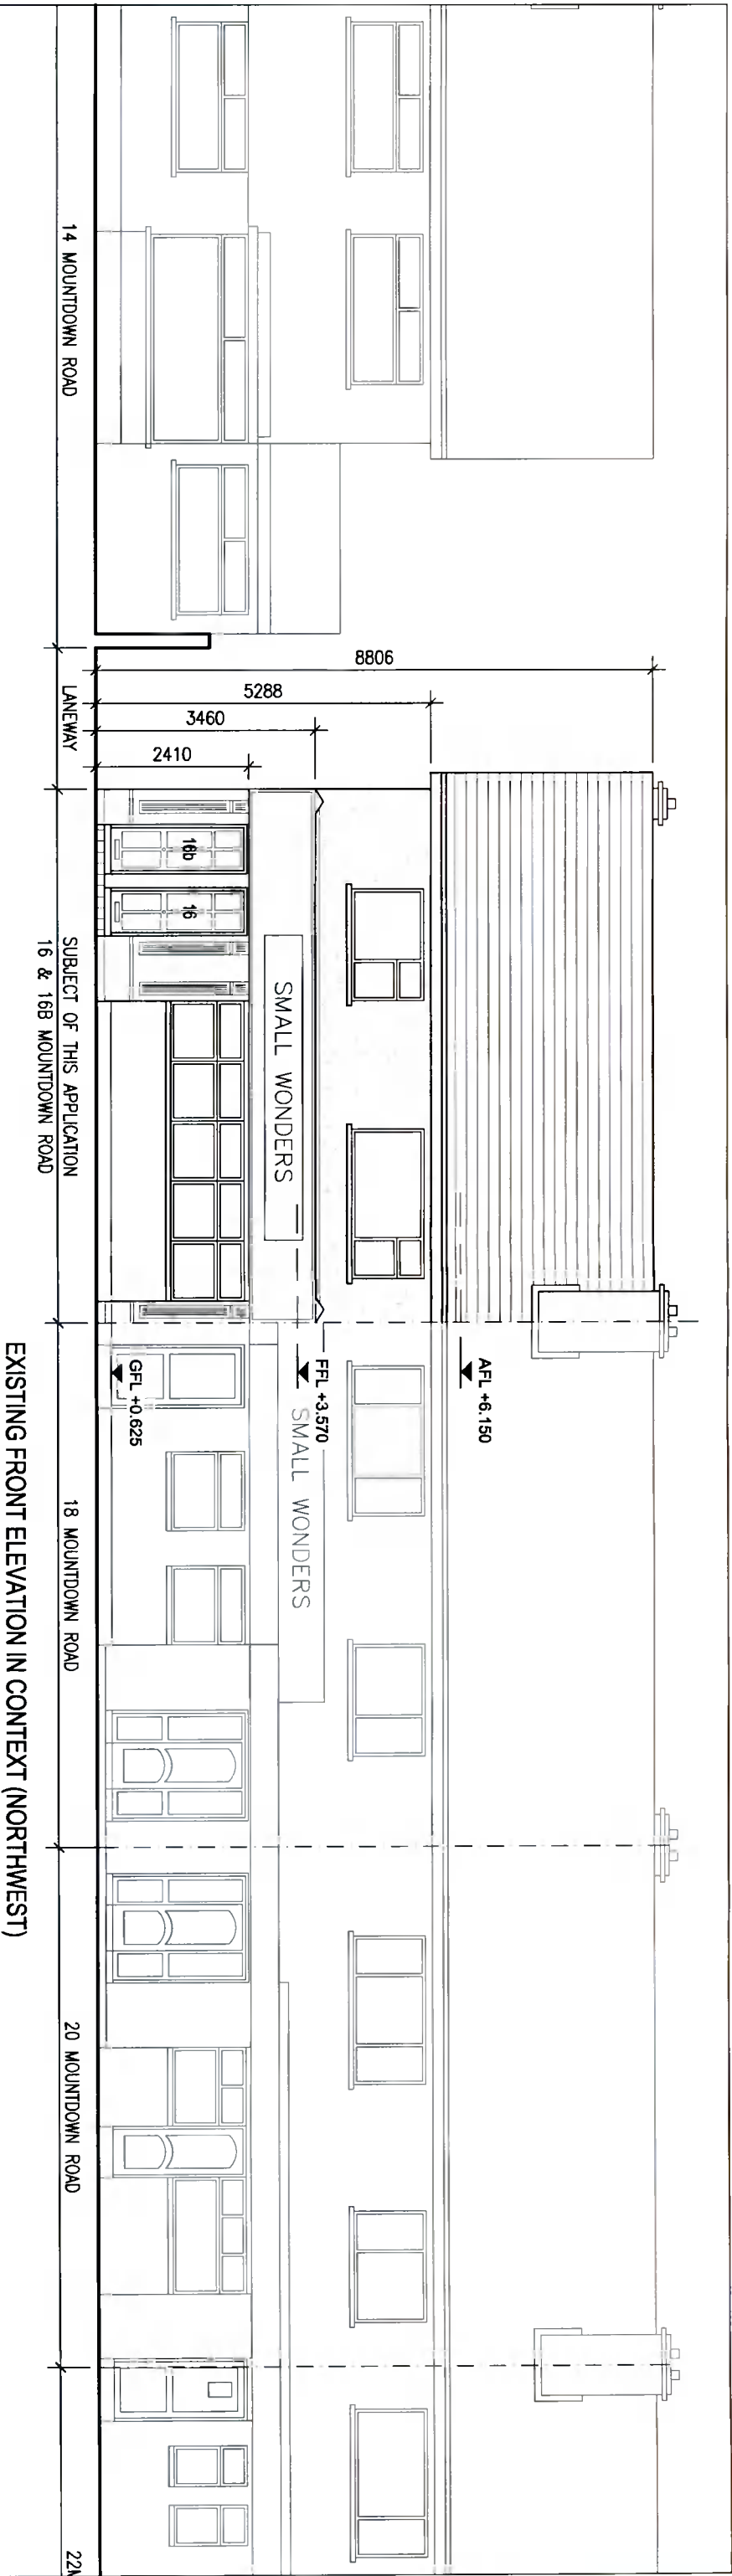


SURVEY

Notes

1. Copyright Reserved
2. Work to figured dimensions only. Do not scale drawing.
3. The contractor is responsible for checking all levels and dimensions on site and shall refer all discrepancies to the Architect
4. Where appropriate, for details of r.c. structure, or mechanical and electrical details, see Engineers drawings
5. Proprietary items shall be fixed in strict accordance with manufacturers instructions.
6. Sizes of proprietary items shall be checked with manufacturer.
7. The contractor shall be responsible for the coordination of structure, finishes and services.


Project		Change of use and alteration/extension to 16 & 16B Mountdown Road, Manor Estate, D12.		The House Architects Architecture & Project Management www.thehousearchitects.ie Father Mathew Hall, 131 Church Street, Smithfield, Dublin 7 tel. 01 507 9990	
Drawing Title		Existing Front & Rear Elevations in Context			
Drawing No		19-014/S003			
Scale	Rev	Drawn	Date		
1:100@A3	0	TC	AUGUST 2019		

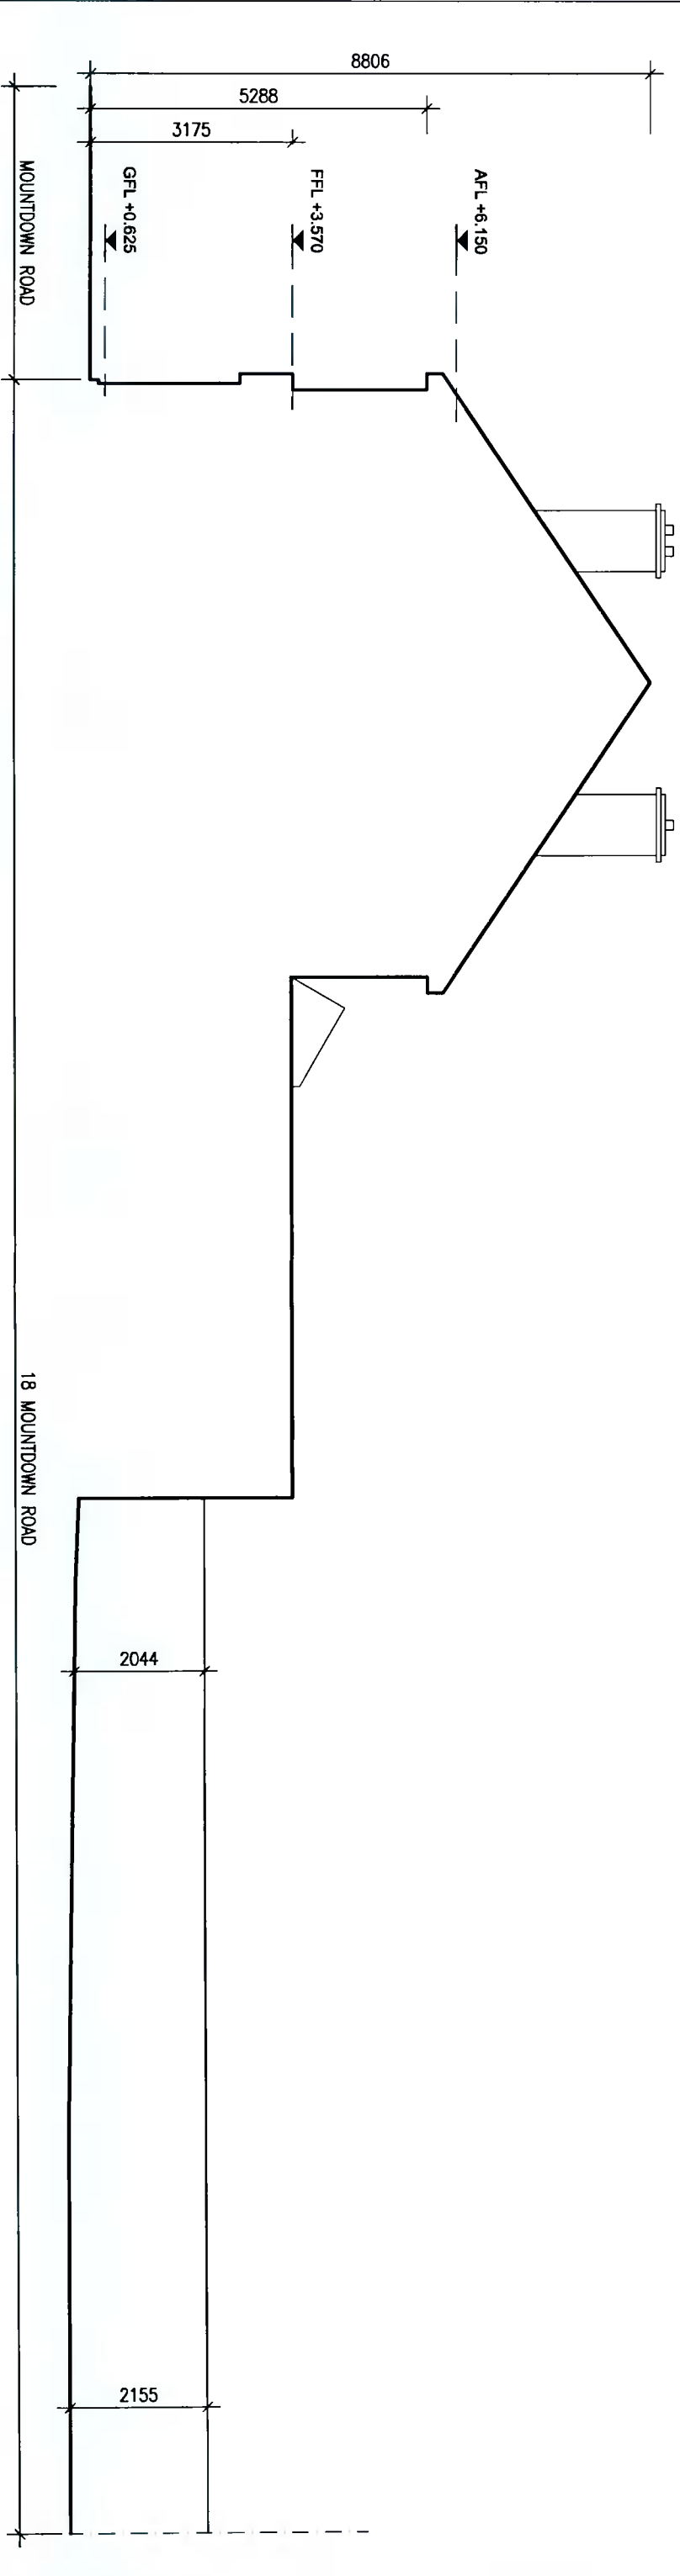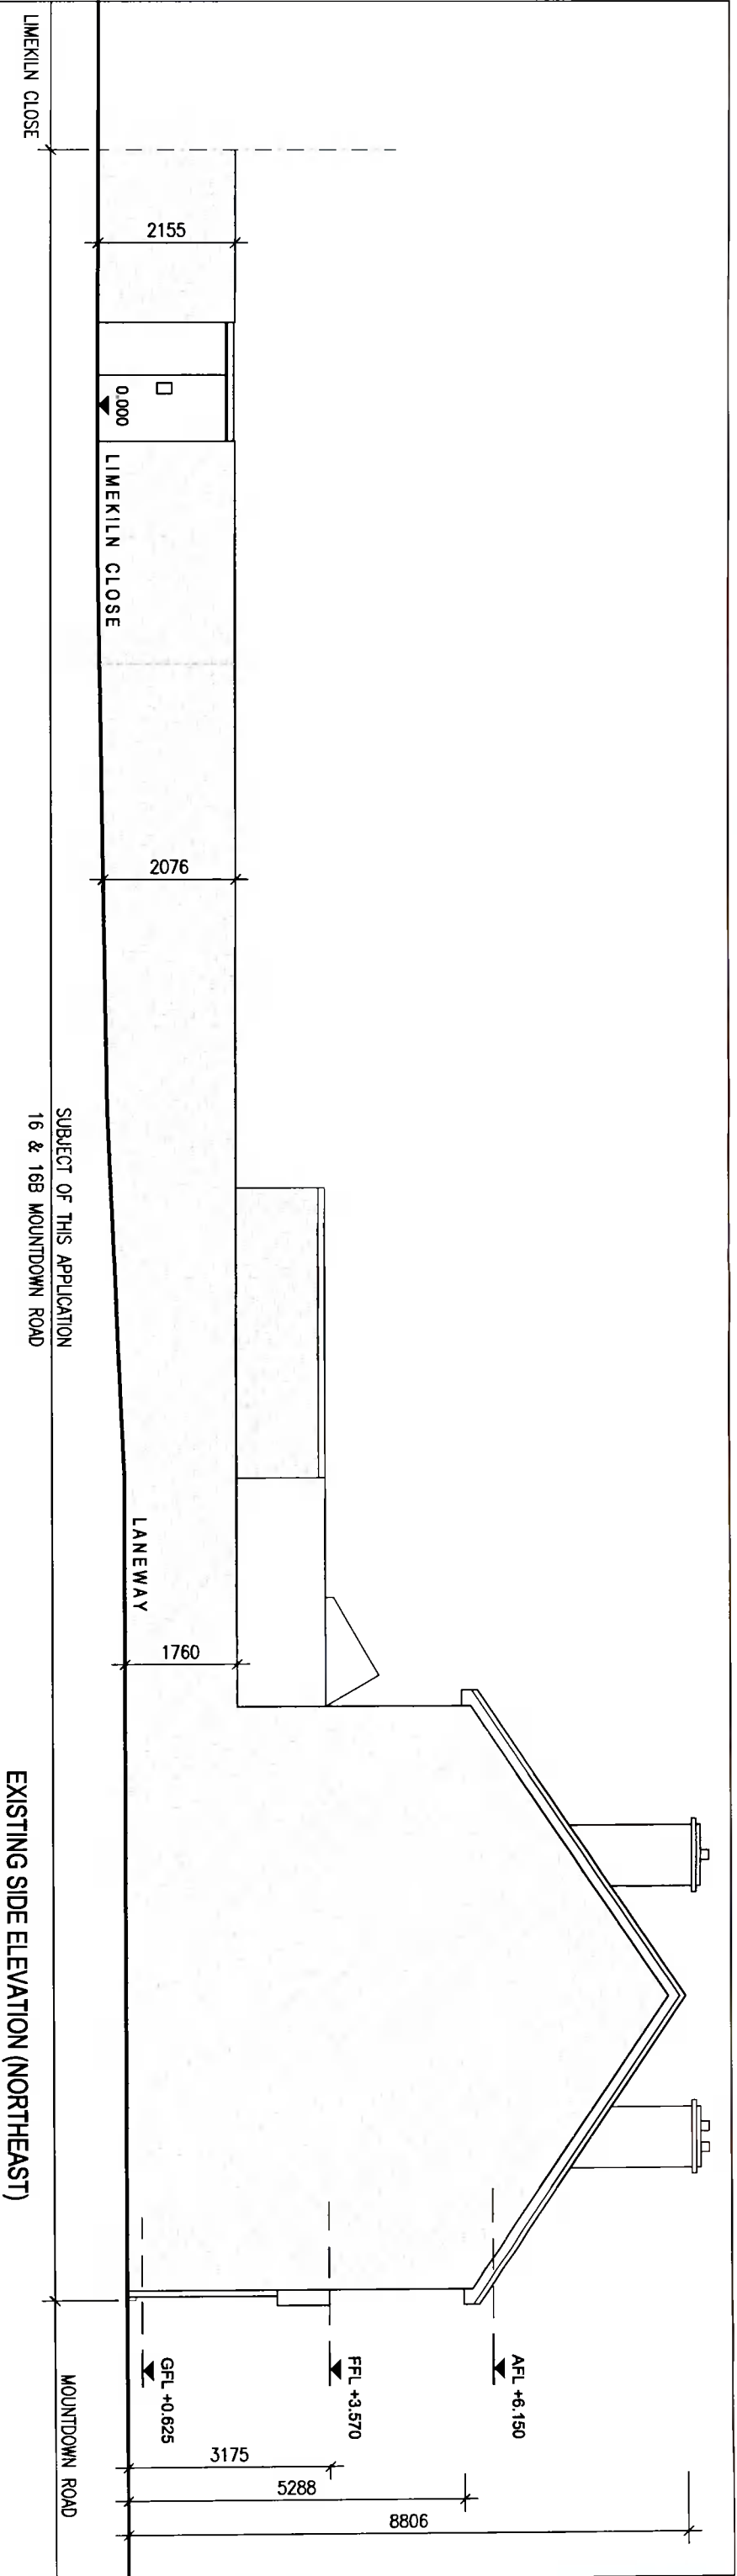



Notes

1. Copyright Reserved
2. Work to figured dimensions only. Do not scale drawing.
3. The contractor is responsible for checking all levels and dimensions on site and shall refer all discrepancies to the Architect
4. Where appropriate, for details of i.e. structure, or mechanical and electrical details, see Engineers drawings
5. Proprietary items shall be fixed in strict accordance with manufacturers instructions.
6. Sizes of proprietary items shall be checked with manufacturer.
7. The contractor shall be responsible for the coordination of structure, finishes and services.

Project	Change of use and alteration/extension to 16 & 16B Mountdown Road, Manor Estate, D12.						
Drawing Title	Existing Side Elevations						
Drawing No	19-014/S004						
Scale	1:100@A3	Rev	0	Drawn	TC	Date	AUGUST 2019



The House Architects
Architecture & Project Management
www.thehousearchitects.ie
Father Matthew Hall, 131 Church Street,
Smithfield, Dublin 7 tel. 01 507 9990

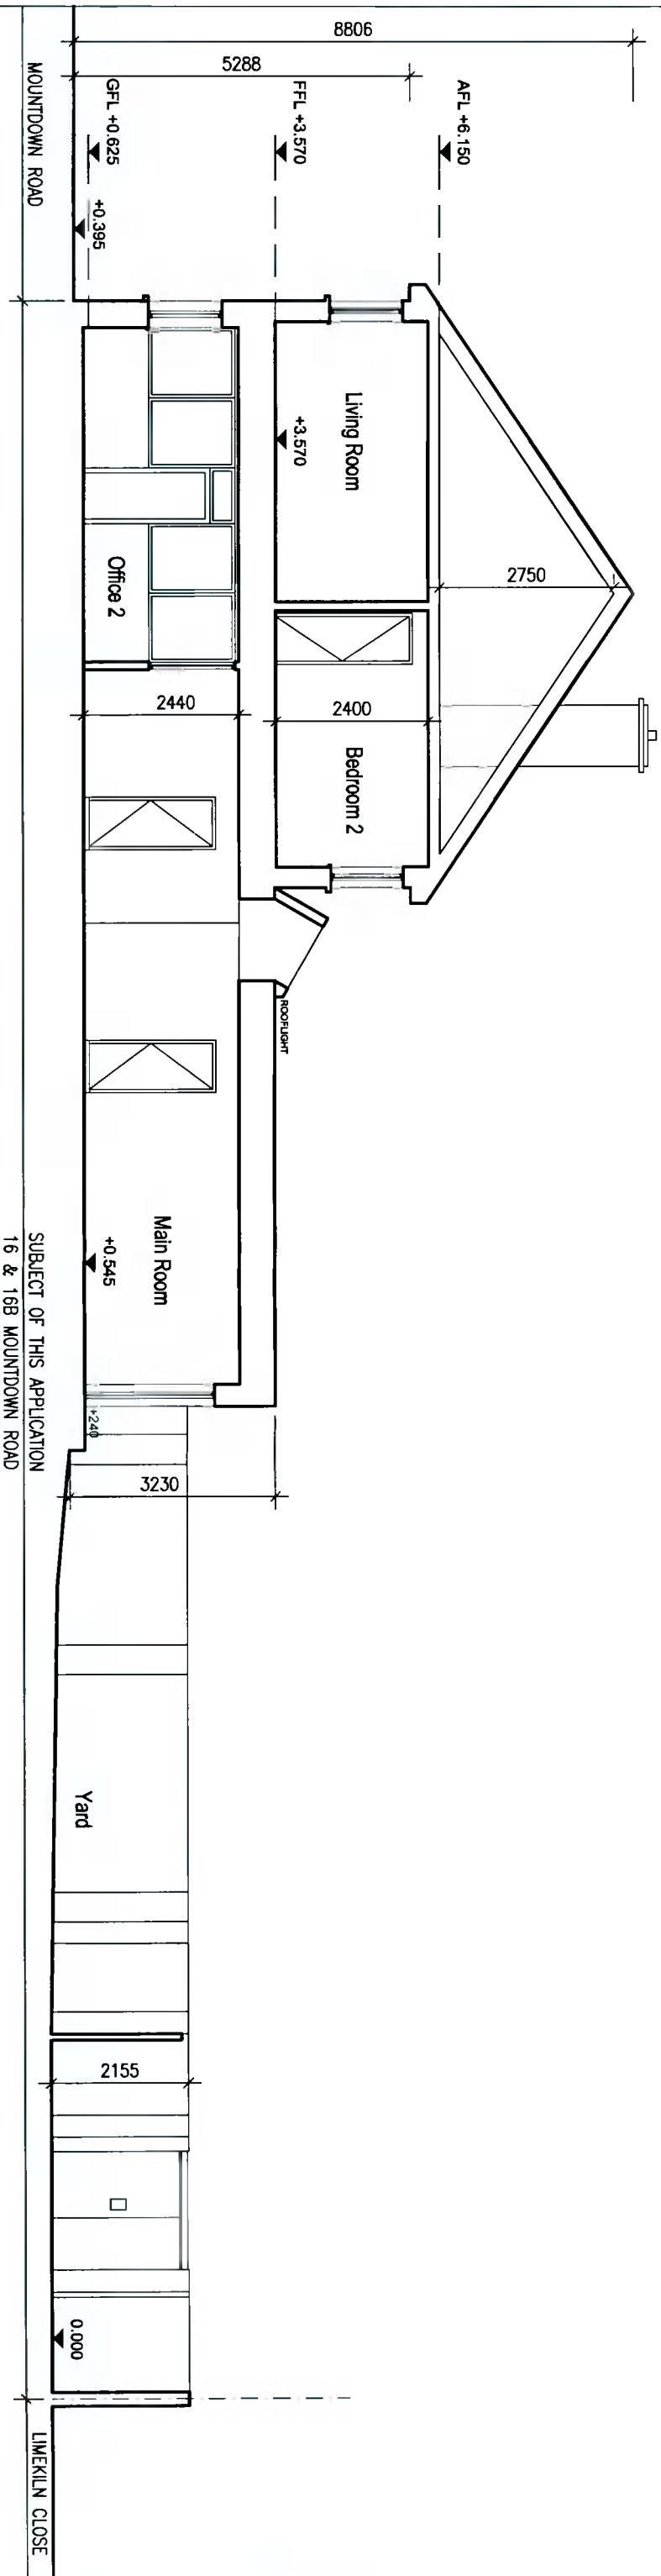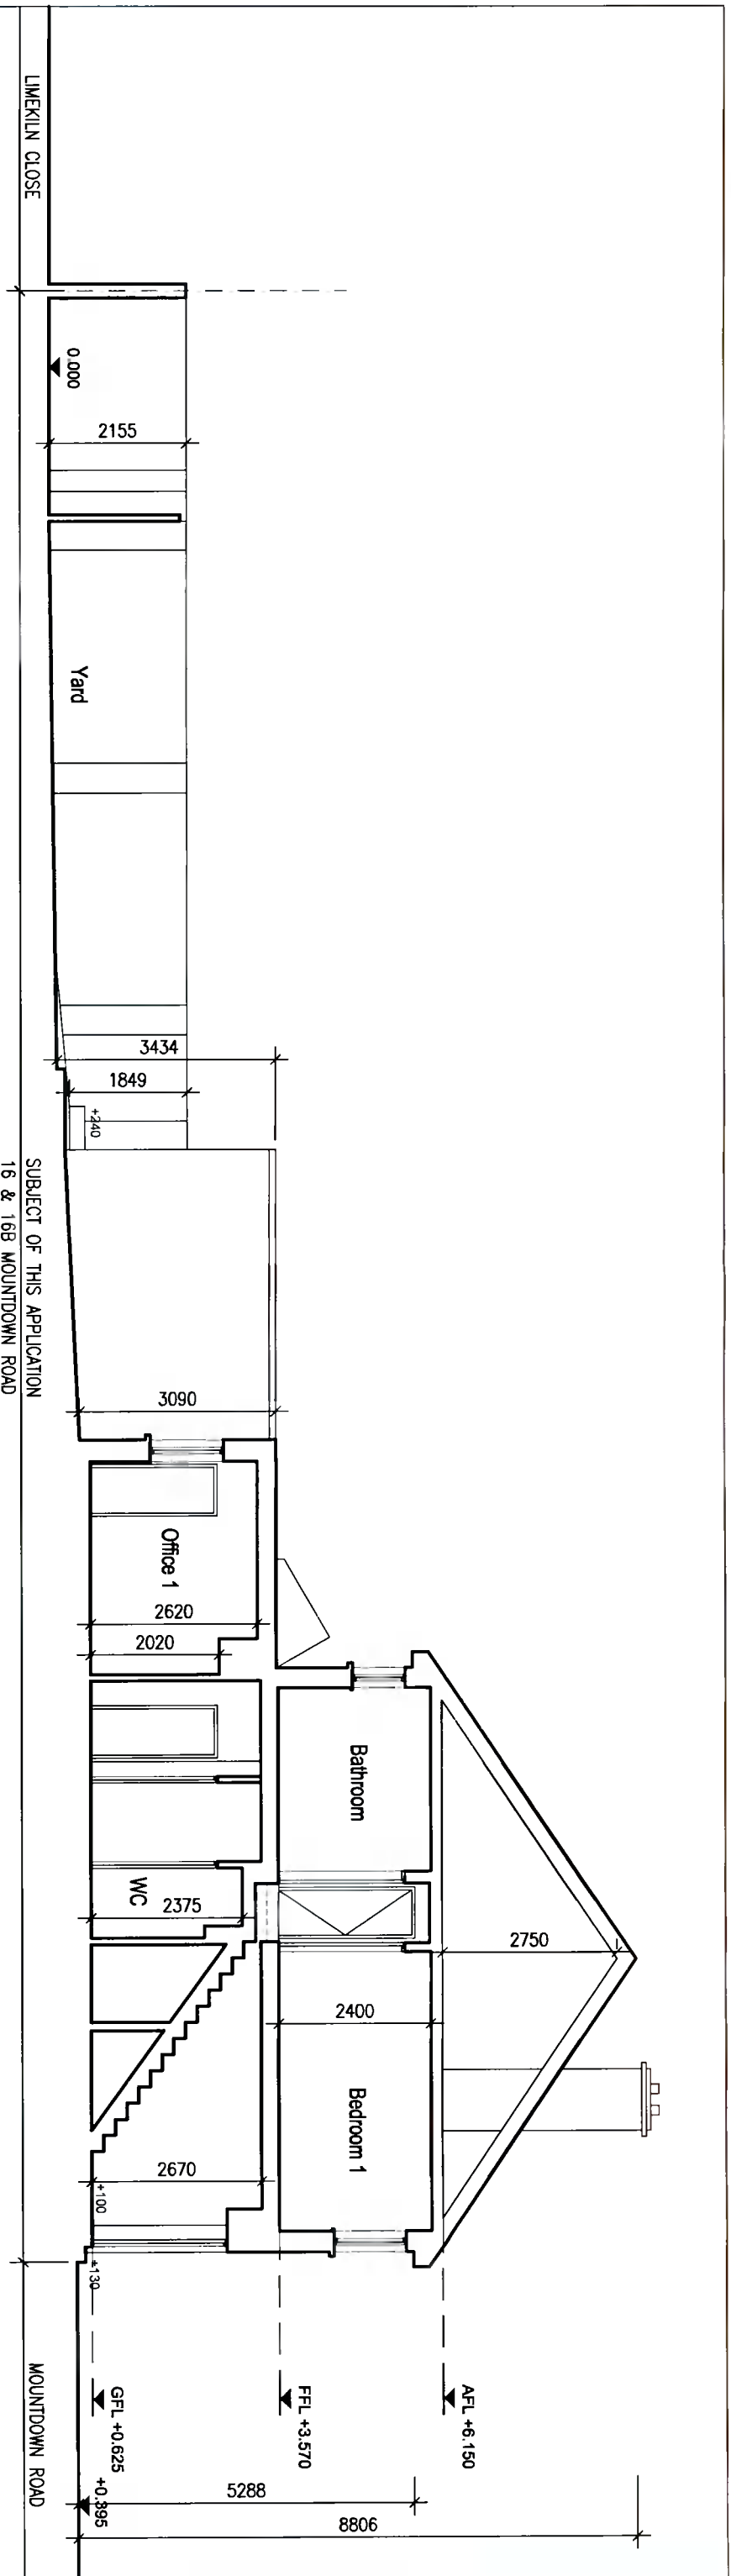

EXISTING SECTION B-B

EXISTING SECTION A-A

SURVEY

Notes

1. Copyright Reserved
2. Work to figured dimensions only. Do not scale drawing.
3. The contractor is responsible for checking all levels and dimensions on site and shall refer all discrepancies to the Architect
4. Where appropriate, for details of r.c. structure, or mechanical and electrical details, see Engineers drawings
5. Proprietary items shall be fixed in strict accordance with manufacturers instructions.
6. Sizes of proprietary items shall be checked with manufacturer.
7. The contractor shall be responsible for the coordination of structure, finishes and services.

**Change of use and alteration/extension to
16 & 16B Mountdown Road, Manor Estate, D12.**

Drawing Title Existing Sections A-A & B-B

Drawing No 19-014/S005




Scale 1:100@A3 Rev 0 Drawn TC Date AUGUST 2019

The House Architects
Architecture & Project Management

www.thehousearchitects.ie




Father Matthew Hall, 131 Church Street,
Smithfield, Dublin 7 tel. 01 507 9990

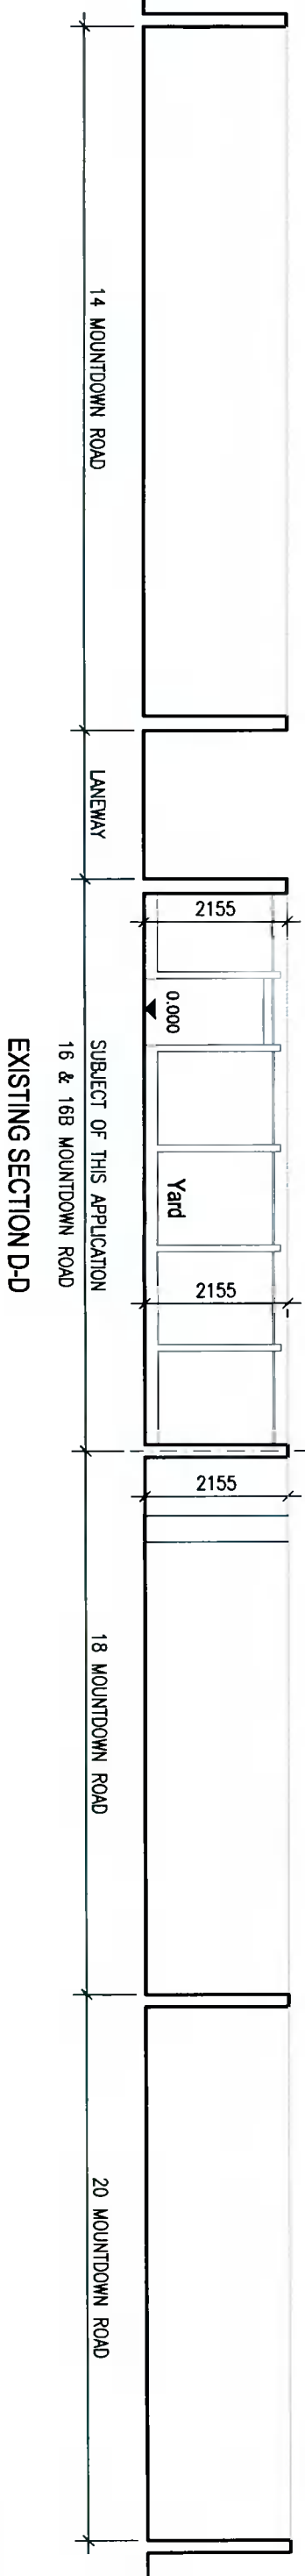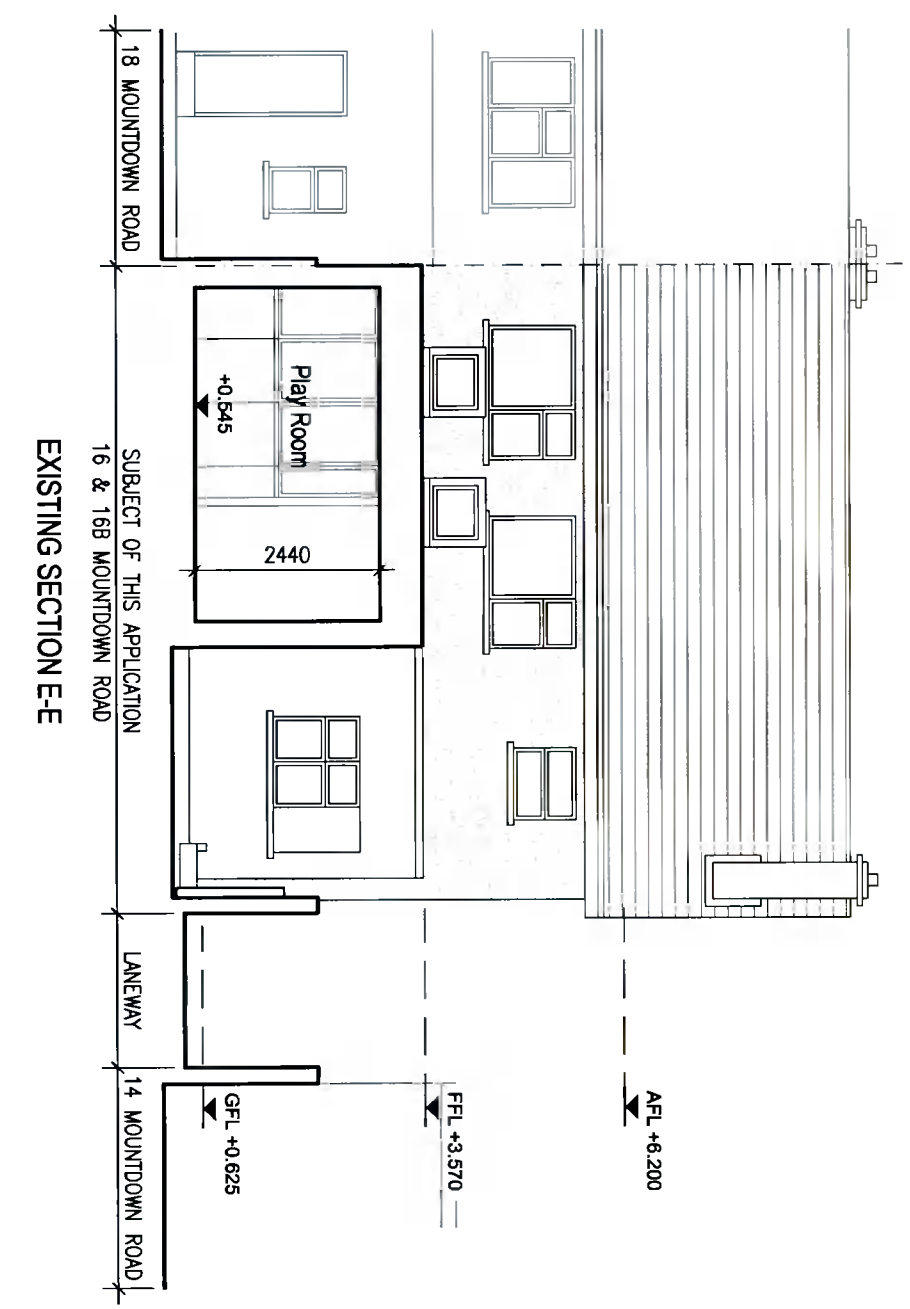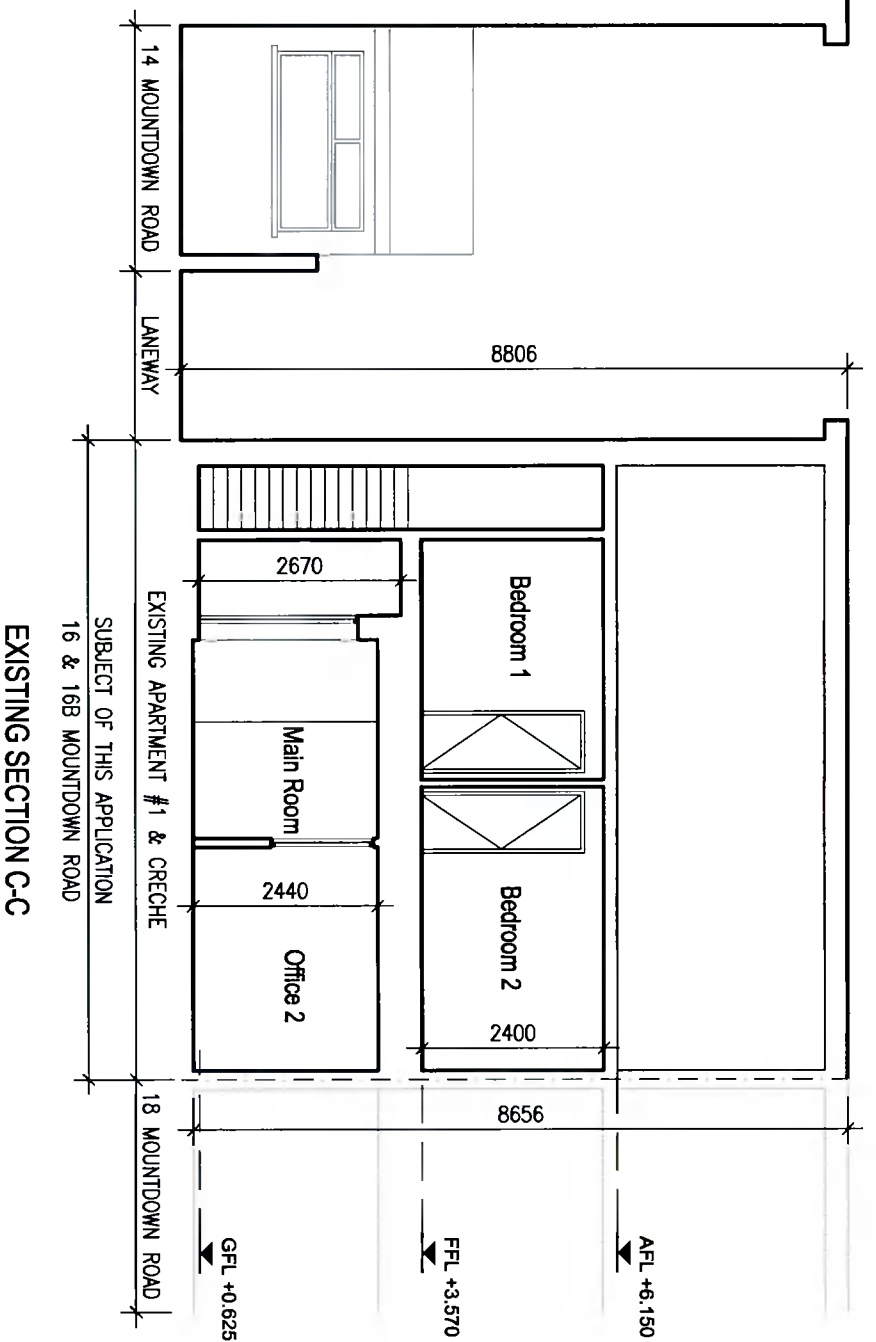

SURVEY

- Notes
1. Copyright Reserved
 2. Work to figured dimensions only. Do not scale drawing.
 3. The contractor is responsible for checking all levels and dimensions on site and shall refer all discrepancies to the Architect
 4. Where appropriate, for details of r.c. structure, or mechanical and electrical details, see Engineers drawings
 5. Proprietary items shall be fixed in strict accordance with manufacturers instructions.
 6. Sizes of proprietary items shall be checked with manufacturer.
 7. The contractor shall be responsible for the coordination of structure, finishes and services.

Project		Change of use and alteration/extension to 16 & 16B Mountdown Road, Manor Estate, D12.	
Drawing Title		Existing Sections C-C, D-D & E-E	
Drawing No		19-014/S006	
Scale	1:100@A3	Rev	0
Drawn	TC	Date	AUGUST 2019



The House Architects
Architecture & Project Management
www.thehousearchitects.ie
Father Mathew Hall, 131 Church Street,
Smithfield, Dublin 7 tel. 01 507 9990